


ATTN: STEVE / ROSEMARY
 FROM: KIAMI/O
 Page 01

12/17/99

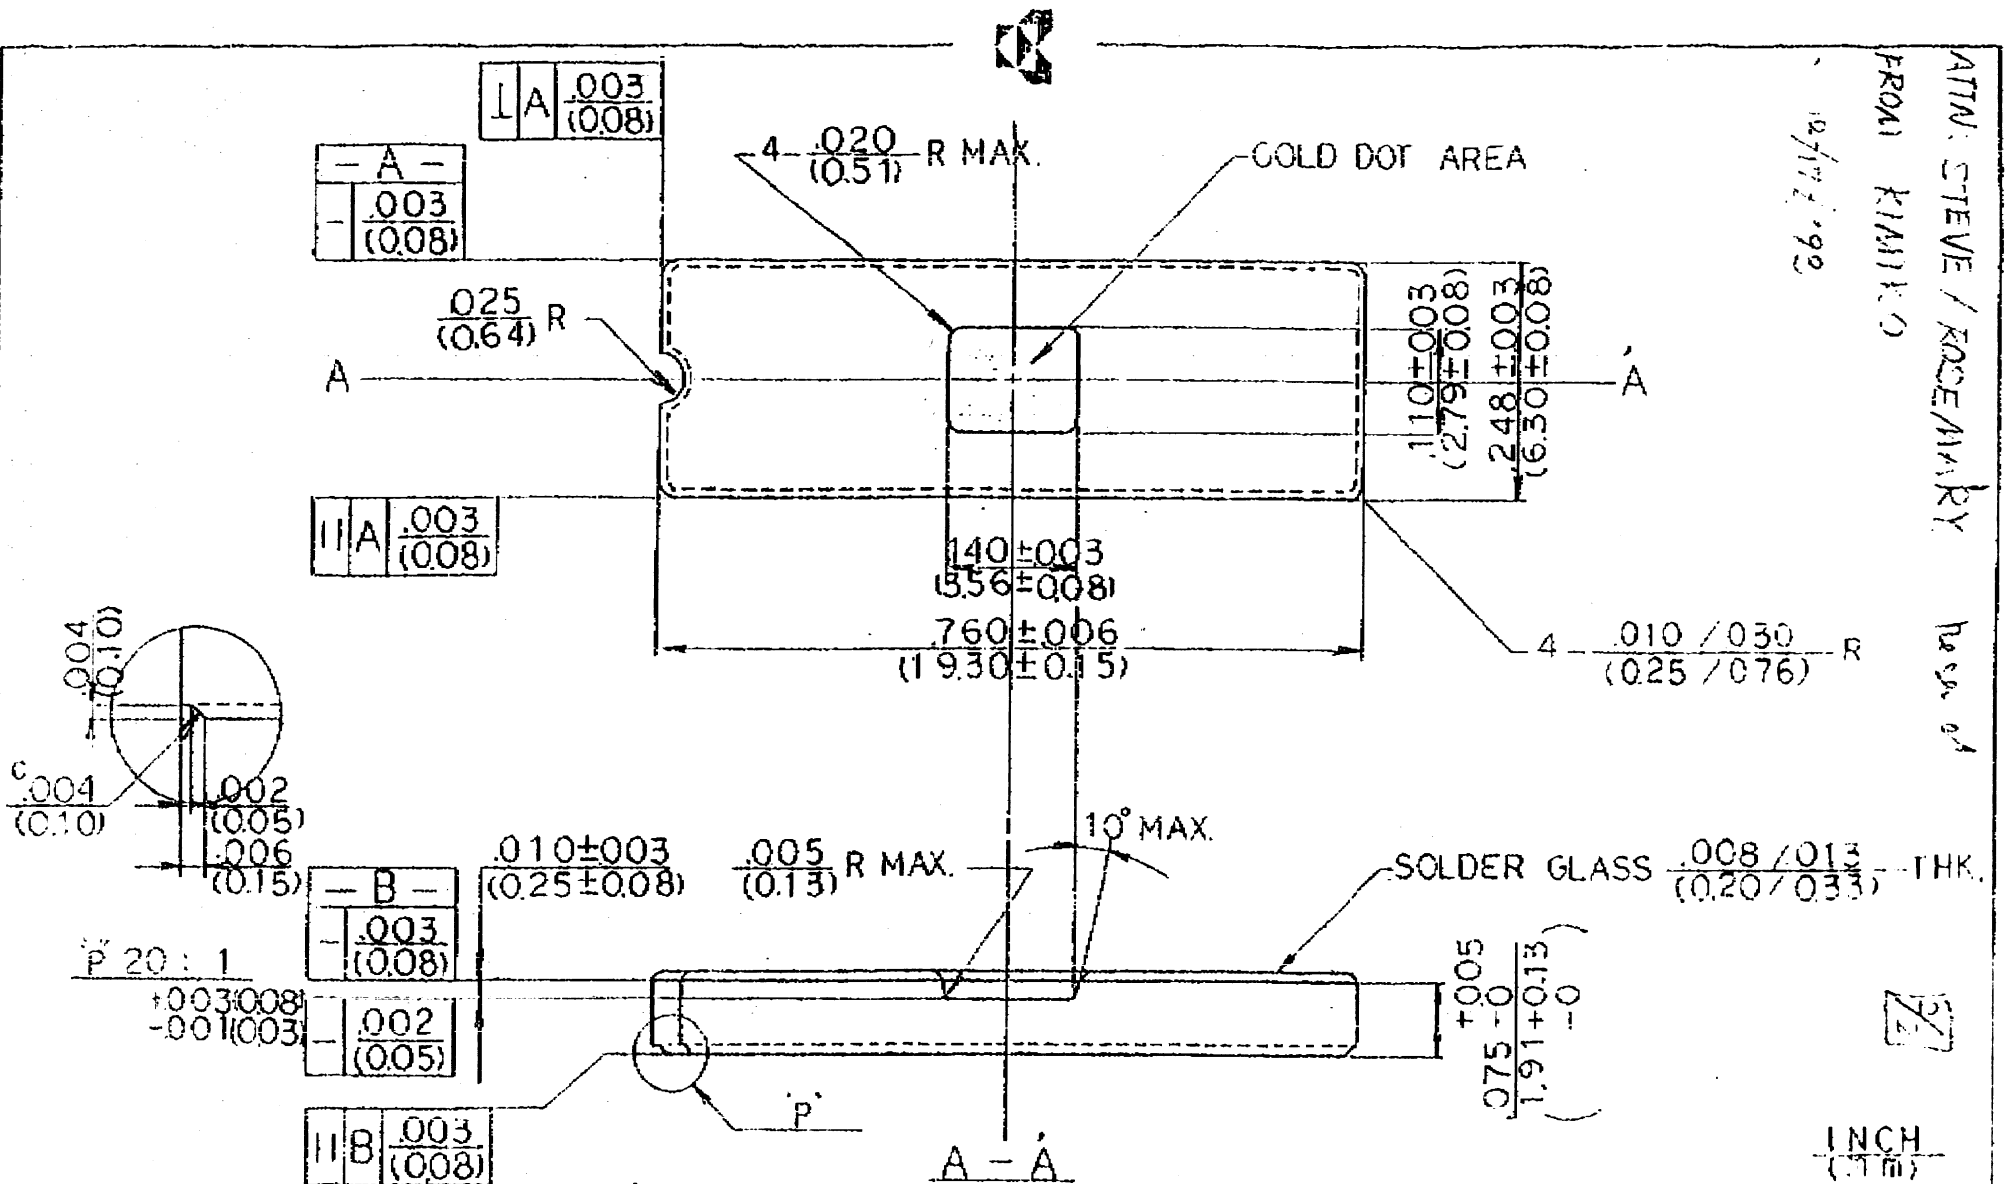

MODIFICATIONS	NAME 14/16 SSI A/C BASE CAV10 (10x140)		TOLERANCES: DIMENSIONS UNLESS OTHERWISE SPECIFIED	DRAWN <i>[Signature]</i>	CHECKED <i>[Signature]</i>
	SCALE 5 : 1	MATERIAL AL ₂ O ₃ 90% MIN (BLACK)		APPROVED <i>[Signature]</i>	DATE APR 20 1983
	KYOCERA CORPORATION		KYOTO JAPAN	Doc. No. BB-01454-1	